


REFLECTED CEILING PLAN AND ELECTRICAL NOTES:

- 1
- INSTALL AND PURCHASE NEW CEILING FAN, PROVIDE FAN WALL SWITCH/SEPARATE REMOTE
- 2
- INSTALL NEW WALL SCONCES WHERE INDICATED- RUN NEW CIRCUIT IN WALL- LOCATE A SWITCH IN LIVING ROOM
- 3
- NEW ELECTRICAL AND LIGHTING WHERE INDICATED. PUT NEW SCONCES ON DIMMABLE SWITCH.
- 4
- NEW SMOKE/CARBON DIOXIDE DETECTORS WHERE INDICATED. SEE NOTES ON T001.00.
- 5
- ALL NEW 'SCREWLESS' SWITCH AND WALL OUTLETS TO REPLACE EXISTING
- 6
- LINE OF 12" HEIGHT SOFFIT AS PER BC 1211.2 TO SERVE AS SMOKE SCREEN AT AREAS NOT BOUNDED BY A FULL HEIGHT PARTITION.
- 7
- SEE ELECTRICAL PANEL NOTE ON DM101.00




NOTE: ALL SWITCHES TO BE DIMMABLE
CONTRACTOR TO LOCATE EXISTING SWITCH IN MASTER CLOSET

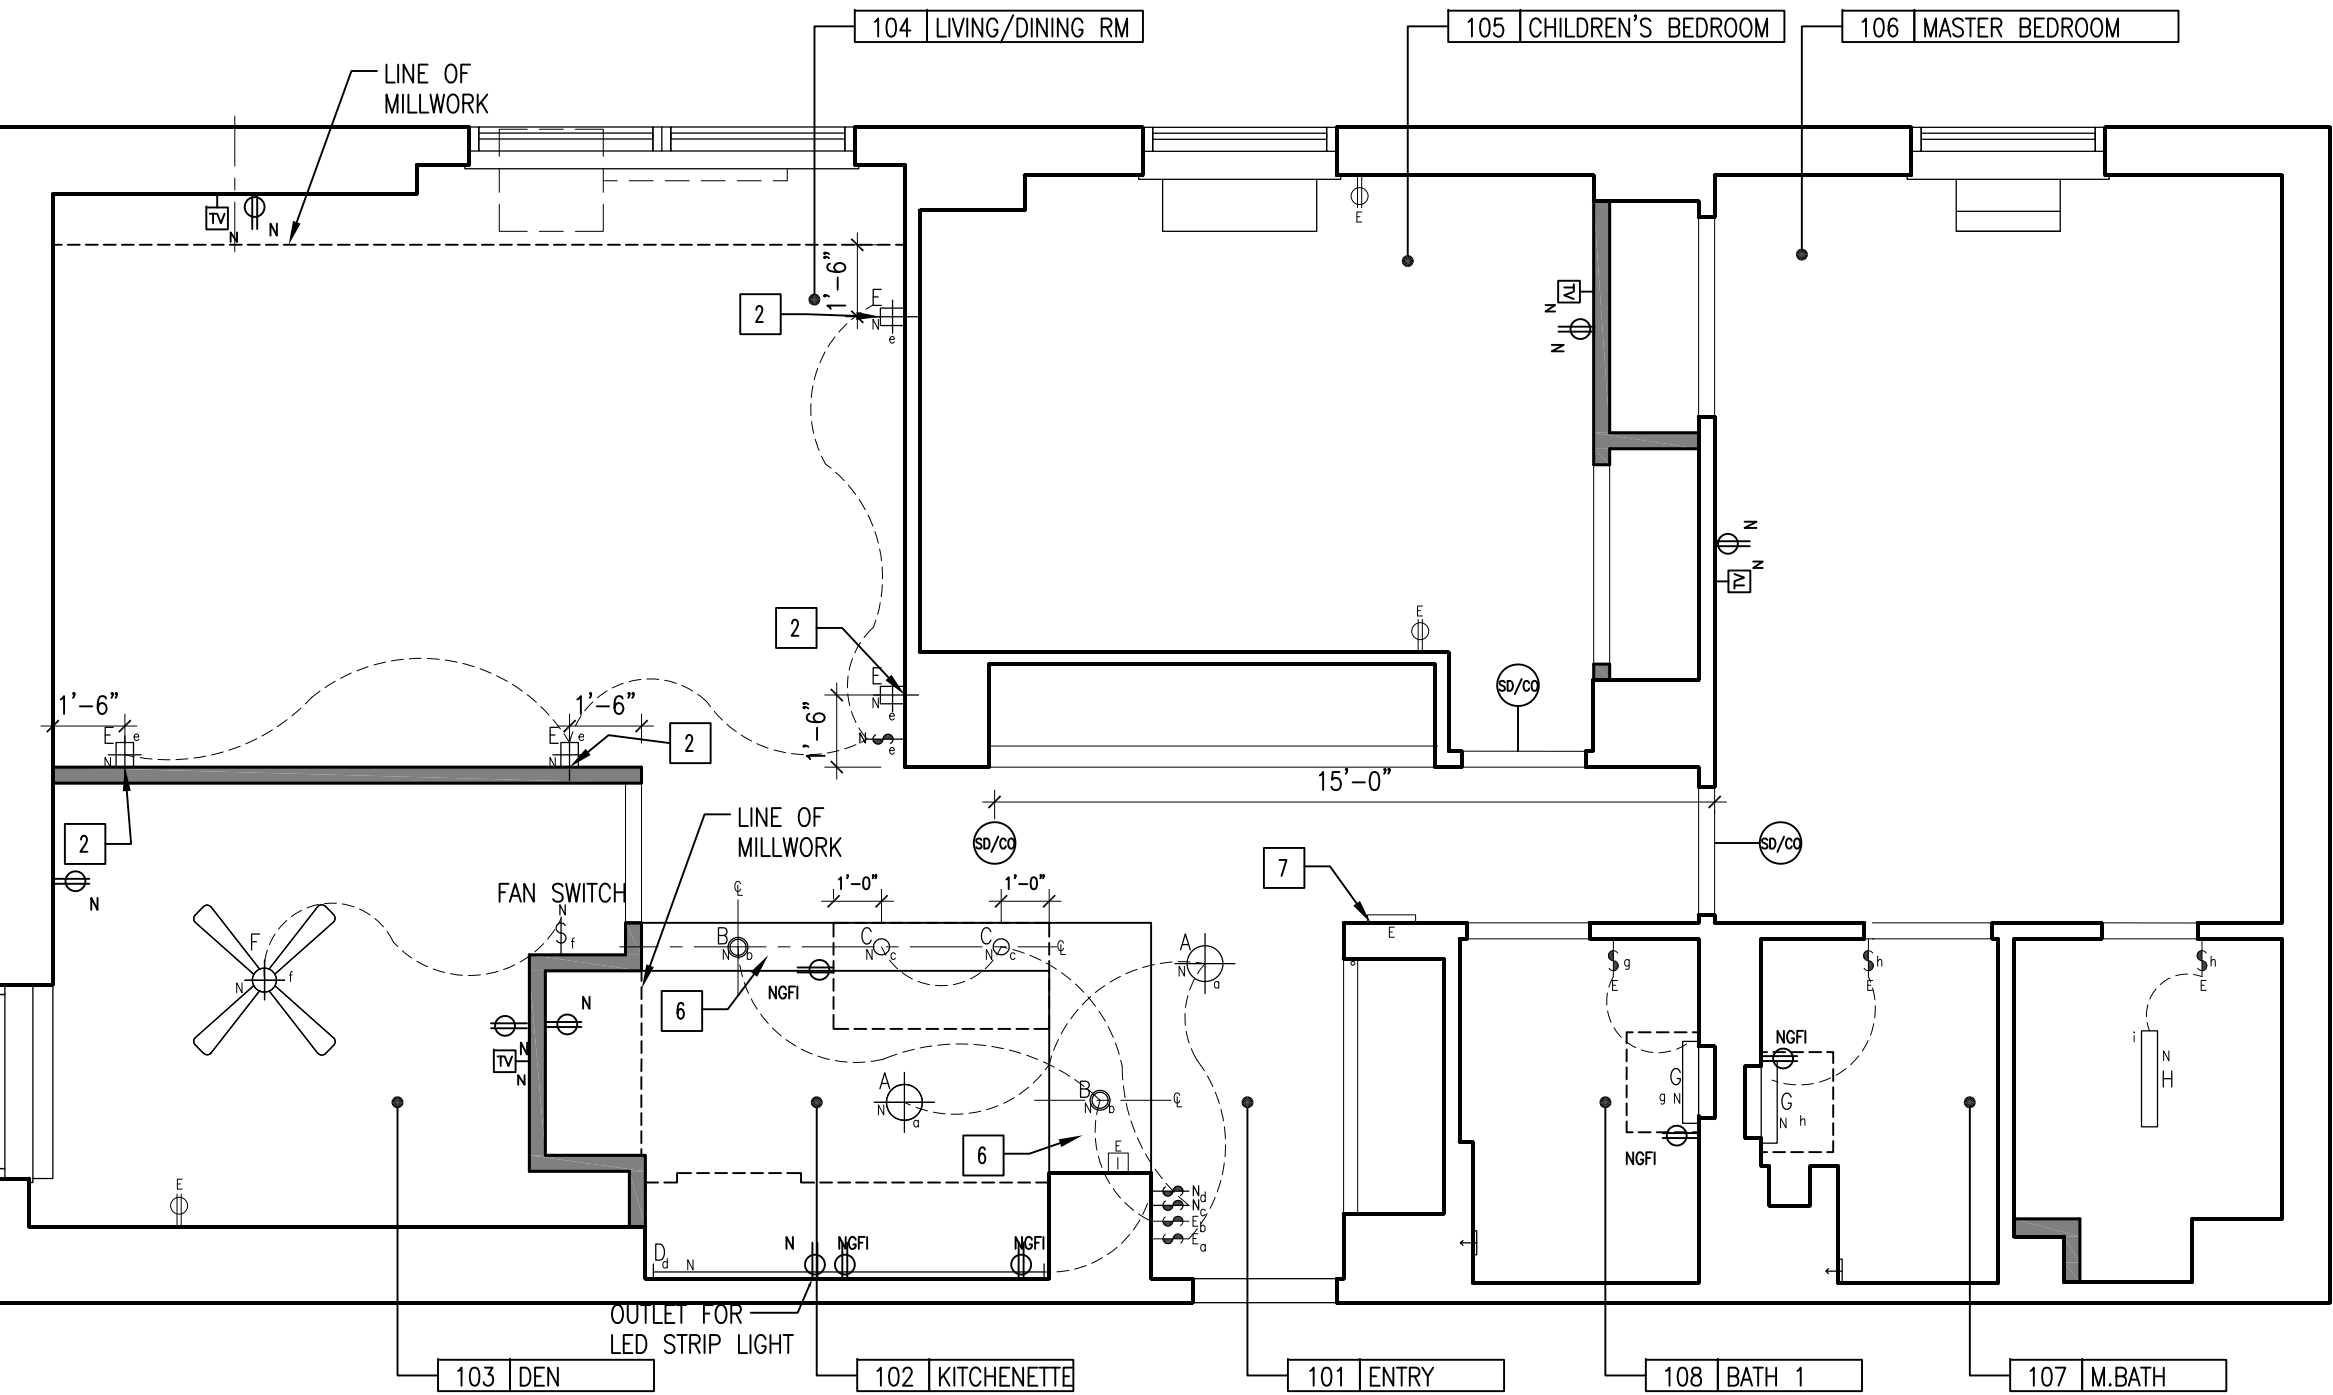

ELECTRIC SYMBOLS

-
- EXISTING DUPLEX OUTLET
-
- PROVIDE NEW DUPLEX OUTLET
-
- PROVIDE NEW GROUND FAULT INTERRUPTER
-
- NEW CABLE TV JACK - CHOP ALL TV WIRING INTO WALL
-
- EXISTING SWITCH
-
- INDICATES SWITCH
NEW DIMMER SWITCH
-
- EXISTING HOUSE INTERCOM
-
- EXISTING ELECTRICAL PANEL
-
- NEW SURFACE MOUNTED LIGHT
-
- NEW RECESSED LIGHTS
-
- NEW PENDANT LED LIGHTS- LEAVE SLACK IN LIGHT FIXTURE
-
- NEW LED PLUG AND PLAY STRIP LIGHT
-
- NEW WALL MOUNT LED SCONCE
-
- NEW CEILING FAN
-
- NEW SURFACE MOUNTED VANITY LIGHT
-
- NEW SURFACE MOUNT LED CLOSET LIGHT
-
- NEW SMOKE DETECTOR/CARBON DIOXIDE DETECTOR
NOTE: SEE SMOKE DETECTOR/CARBON DIOXIDE DETECTOR NOTES ON T001.00

PLUMBING DIAGRAMS:

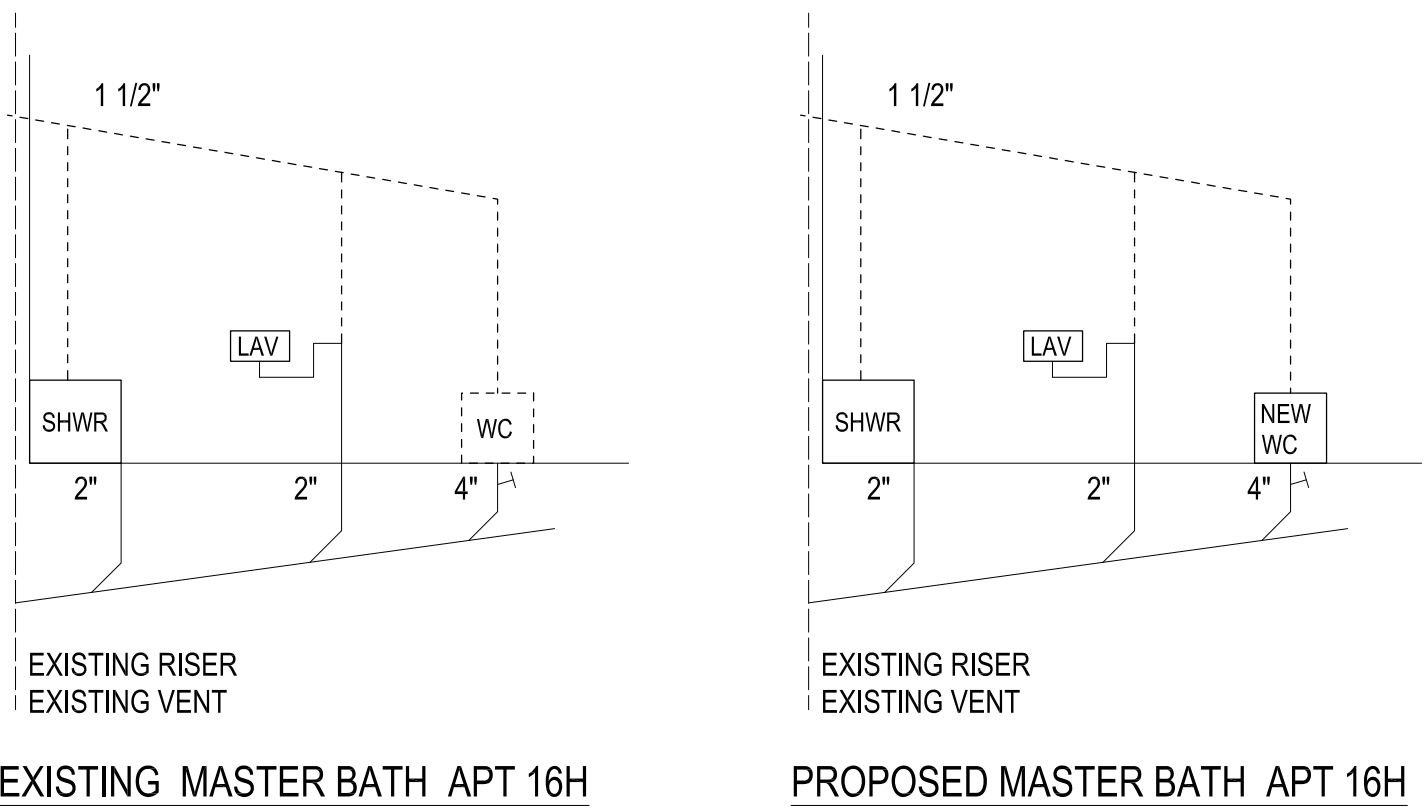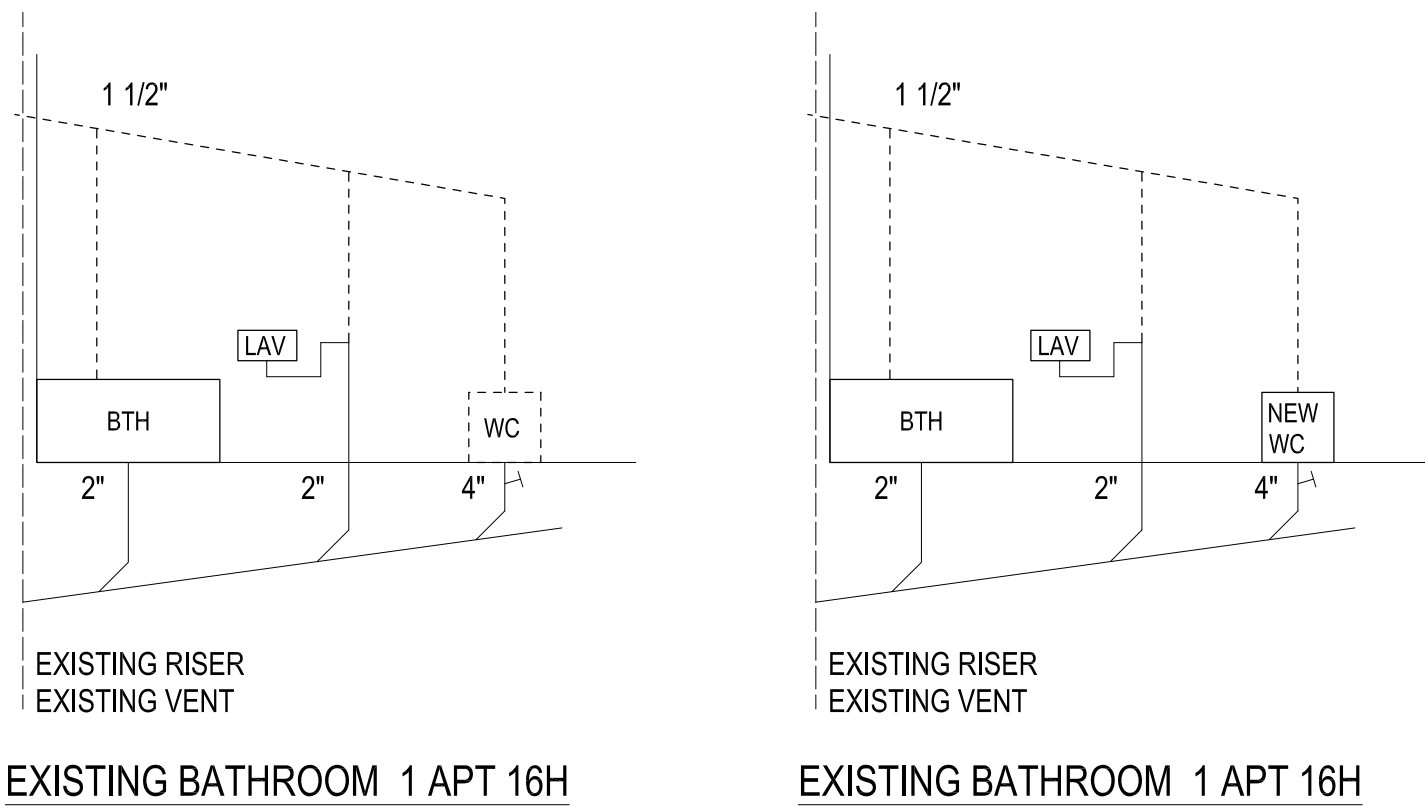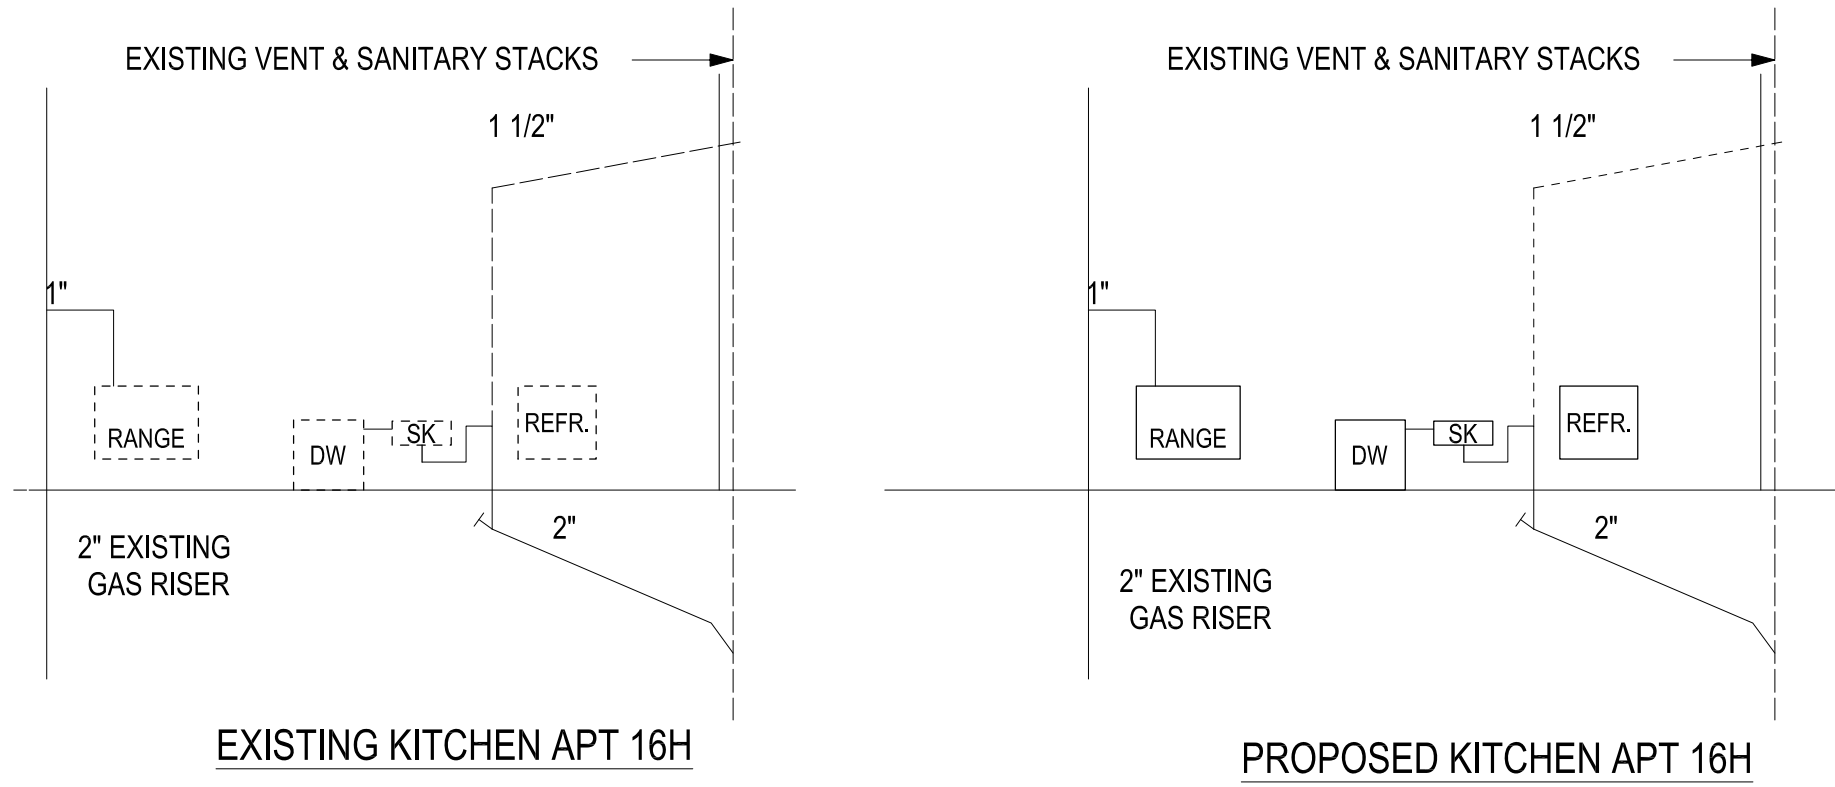

- LEGEND:
- EXISTING TO REMAIN

TO BE REPLACED
- DW

DISHWASHER

RG

RANGE

SK

SINK

REF

REFRIGERATOR
- LAV

LAVATORY

SHWR

SHOWER

BTH

BATHTUB

WC


TOILET

EXD-LAB
ARCHITECTURE, PLLC
220 EAST 57TH STREET, SUITE 2K, NY NY 10021
212.755.0525 INFO@EXD-LAB.COM

CONSULTANTS:

FILING REPRESENTATIVE:
ANTHONY DOMINGO
PROCESS WORKSHOP, PLLC
125 HALLISTER STREET
STATEN ISLAND, NY 10309
917.861.1513

KEY PLAN:

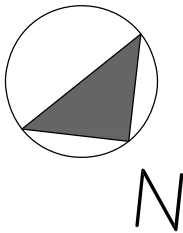

REVISIONS:	
03.18.2019	BID SET
03.12. 2019	DEPARTMENT OF BUILDING SET
03.05.2019	BUILDING APPROVAL SET- REVISION 1
02.26.2019	BUILDING APPROVAL SET

OWNER:

IRA AND JODI CITRON

PROJECT:

CITRON RESIDENCE
1619 3RD AVE, APT. 16H
NEW YORK, NY 10128

ELECTRICAL AND RCP
PLUMBING DIAGRAMS

SEAL & SIGNATURE	DATE:	02.18.19
	PROJECT NO:	0118
	DWG BY:	MC
	DWG NO:	
A102.00		FILE: